


MAIN GATE

Internal Road

MOSQUE

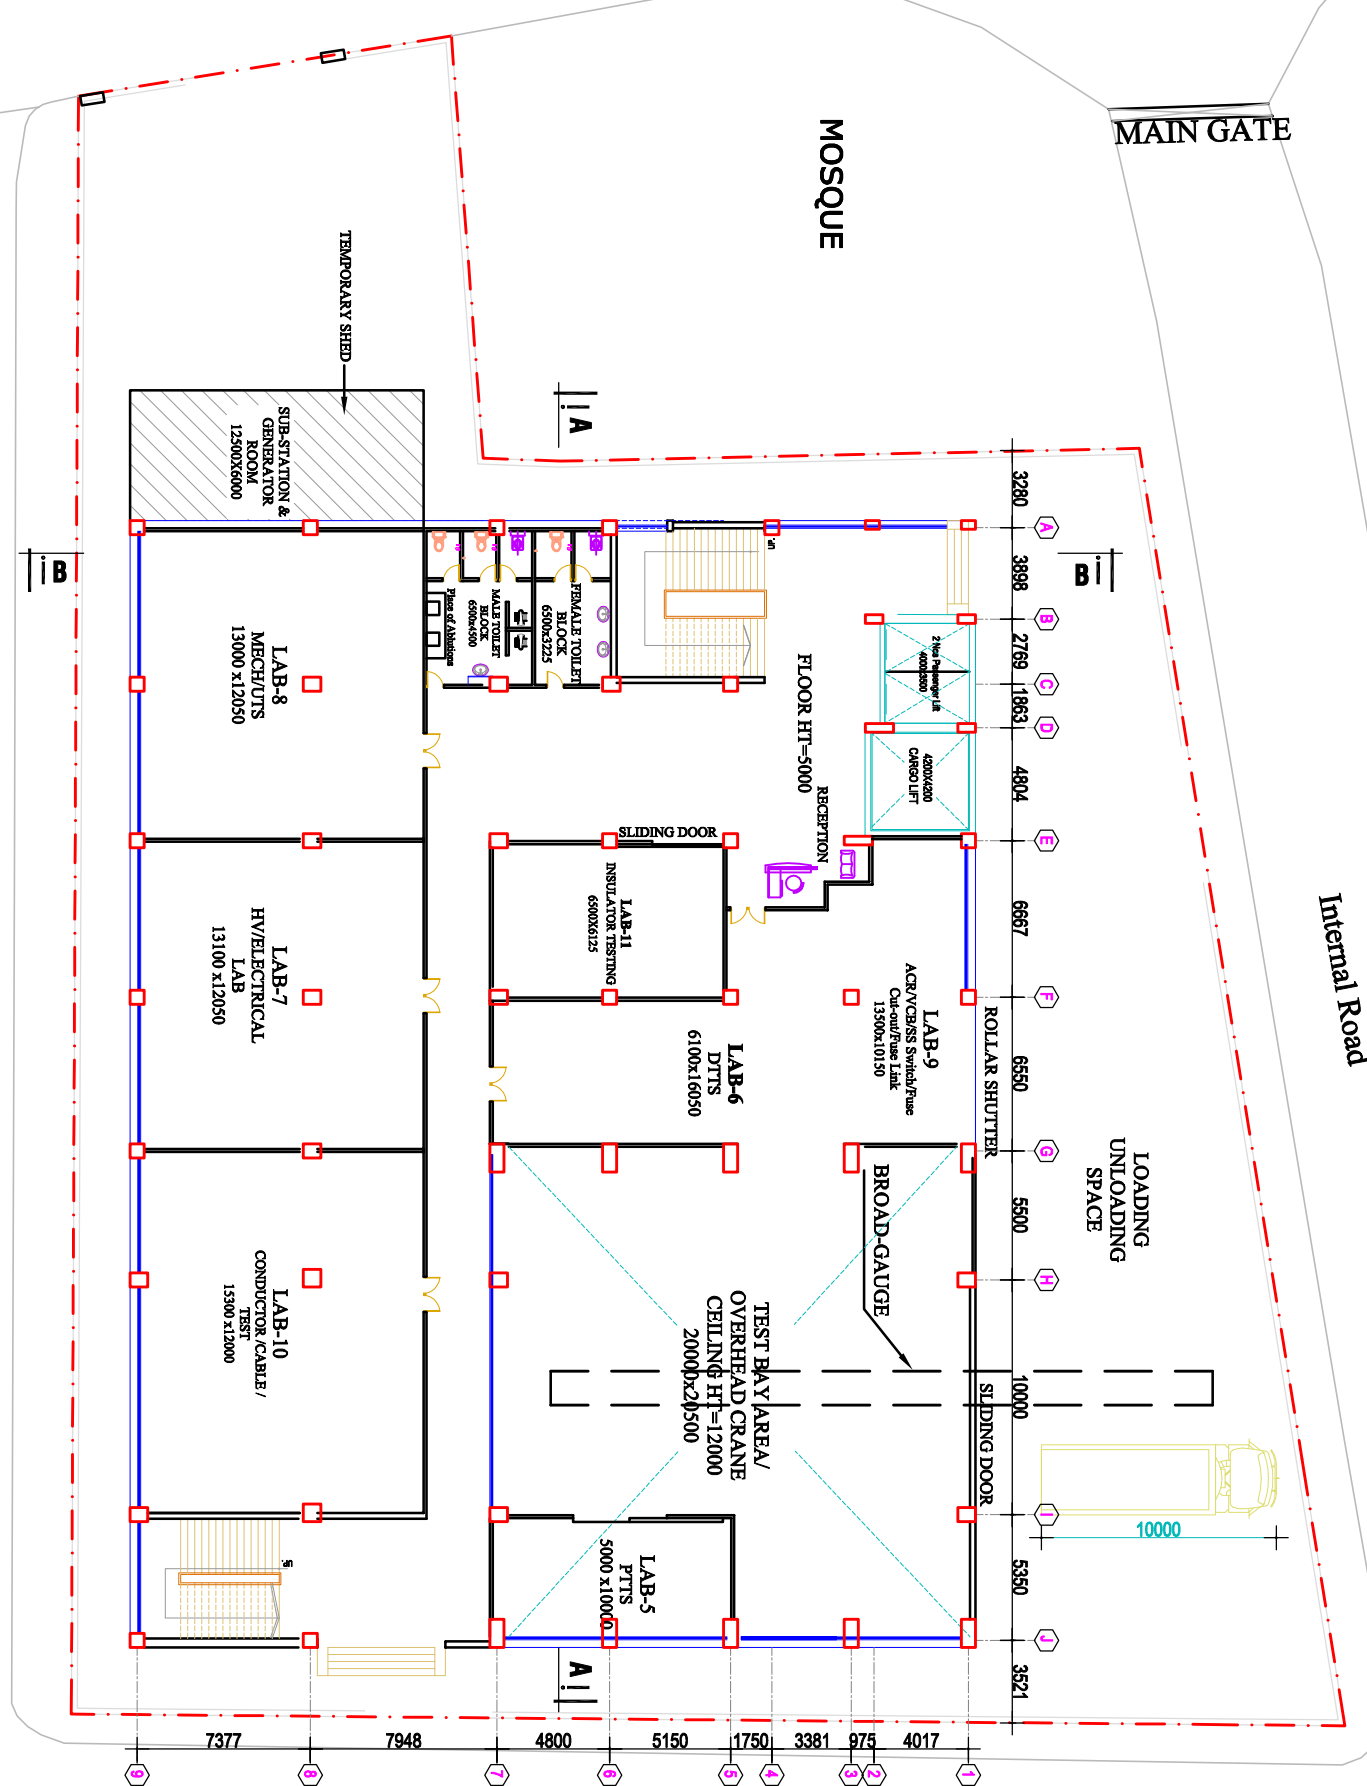

Internal Road


**GROUND FLOOR PLAN**  
 AREA=1728.00 SQM

PROJECT: PROPOSED 3-STORIED TESTING LABORATORY BUILDING WITH 8 STORIED FOUNDATION AT SAVAR, DHAKA

CLIENT: BANGLADESH RURAL ELECTRIFICATION BOARD (BREB)

DESIGN ENGINEER: MD SAZZAD HOSSAIN  
B.Sc. Engrg (CIVIL) FEB-12/31

PROJECT MANAGER:

CONSULTANT:

DATE: JAN./2018

CAD BY: NADIM HOSSAIN

SHEET NO: A-01

DRWG. TITLE: GROUND FLOOR PLAN


**NRECA International**  
 House 33/A (1st floor), Road 99  
 Gulshan-2, Dhaka-1212, Bangladesh